


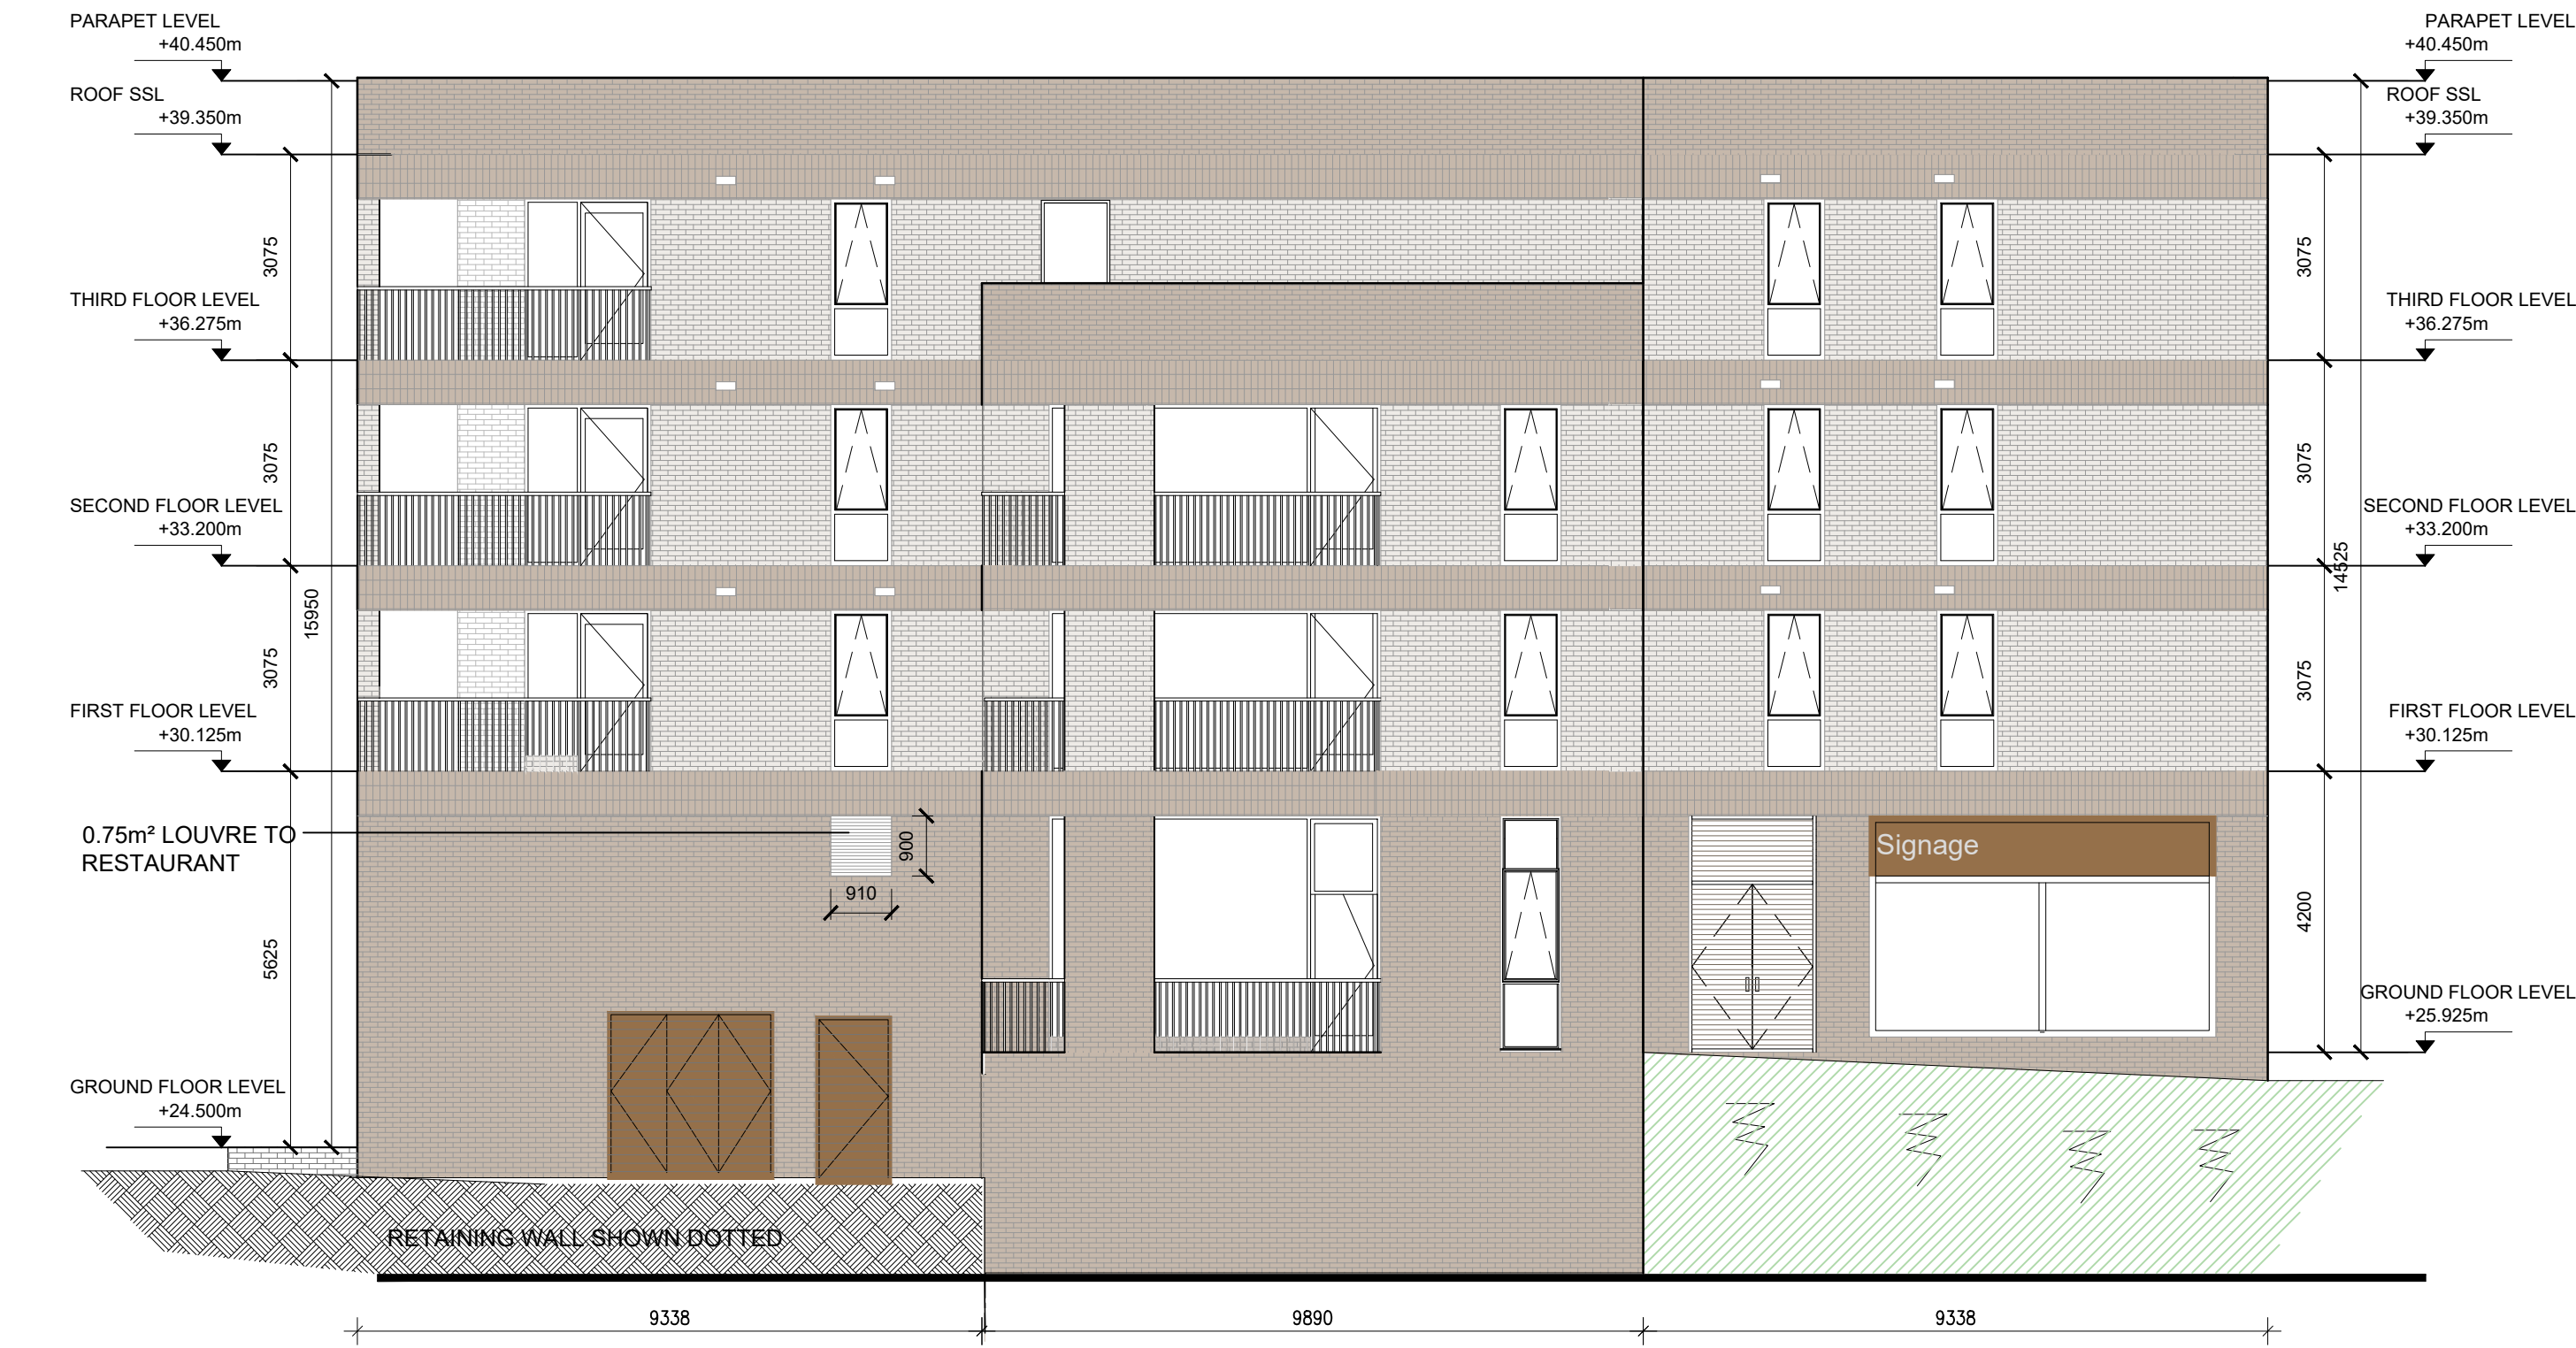


1 Block A - Proposed North Elevation
6304 1:100




2 Block A - Proposed West Elevation
6304 1:100



3 Block A - Proposed South Elevation
6304 1:100

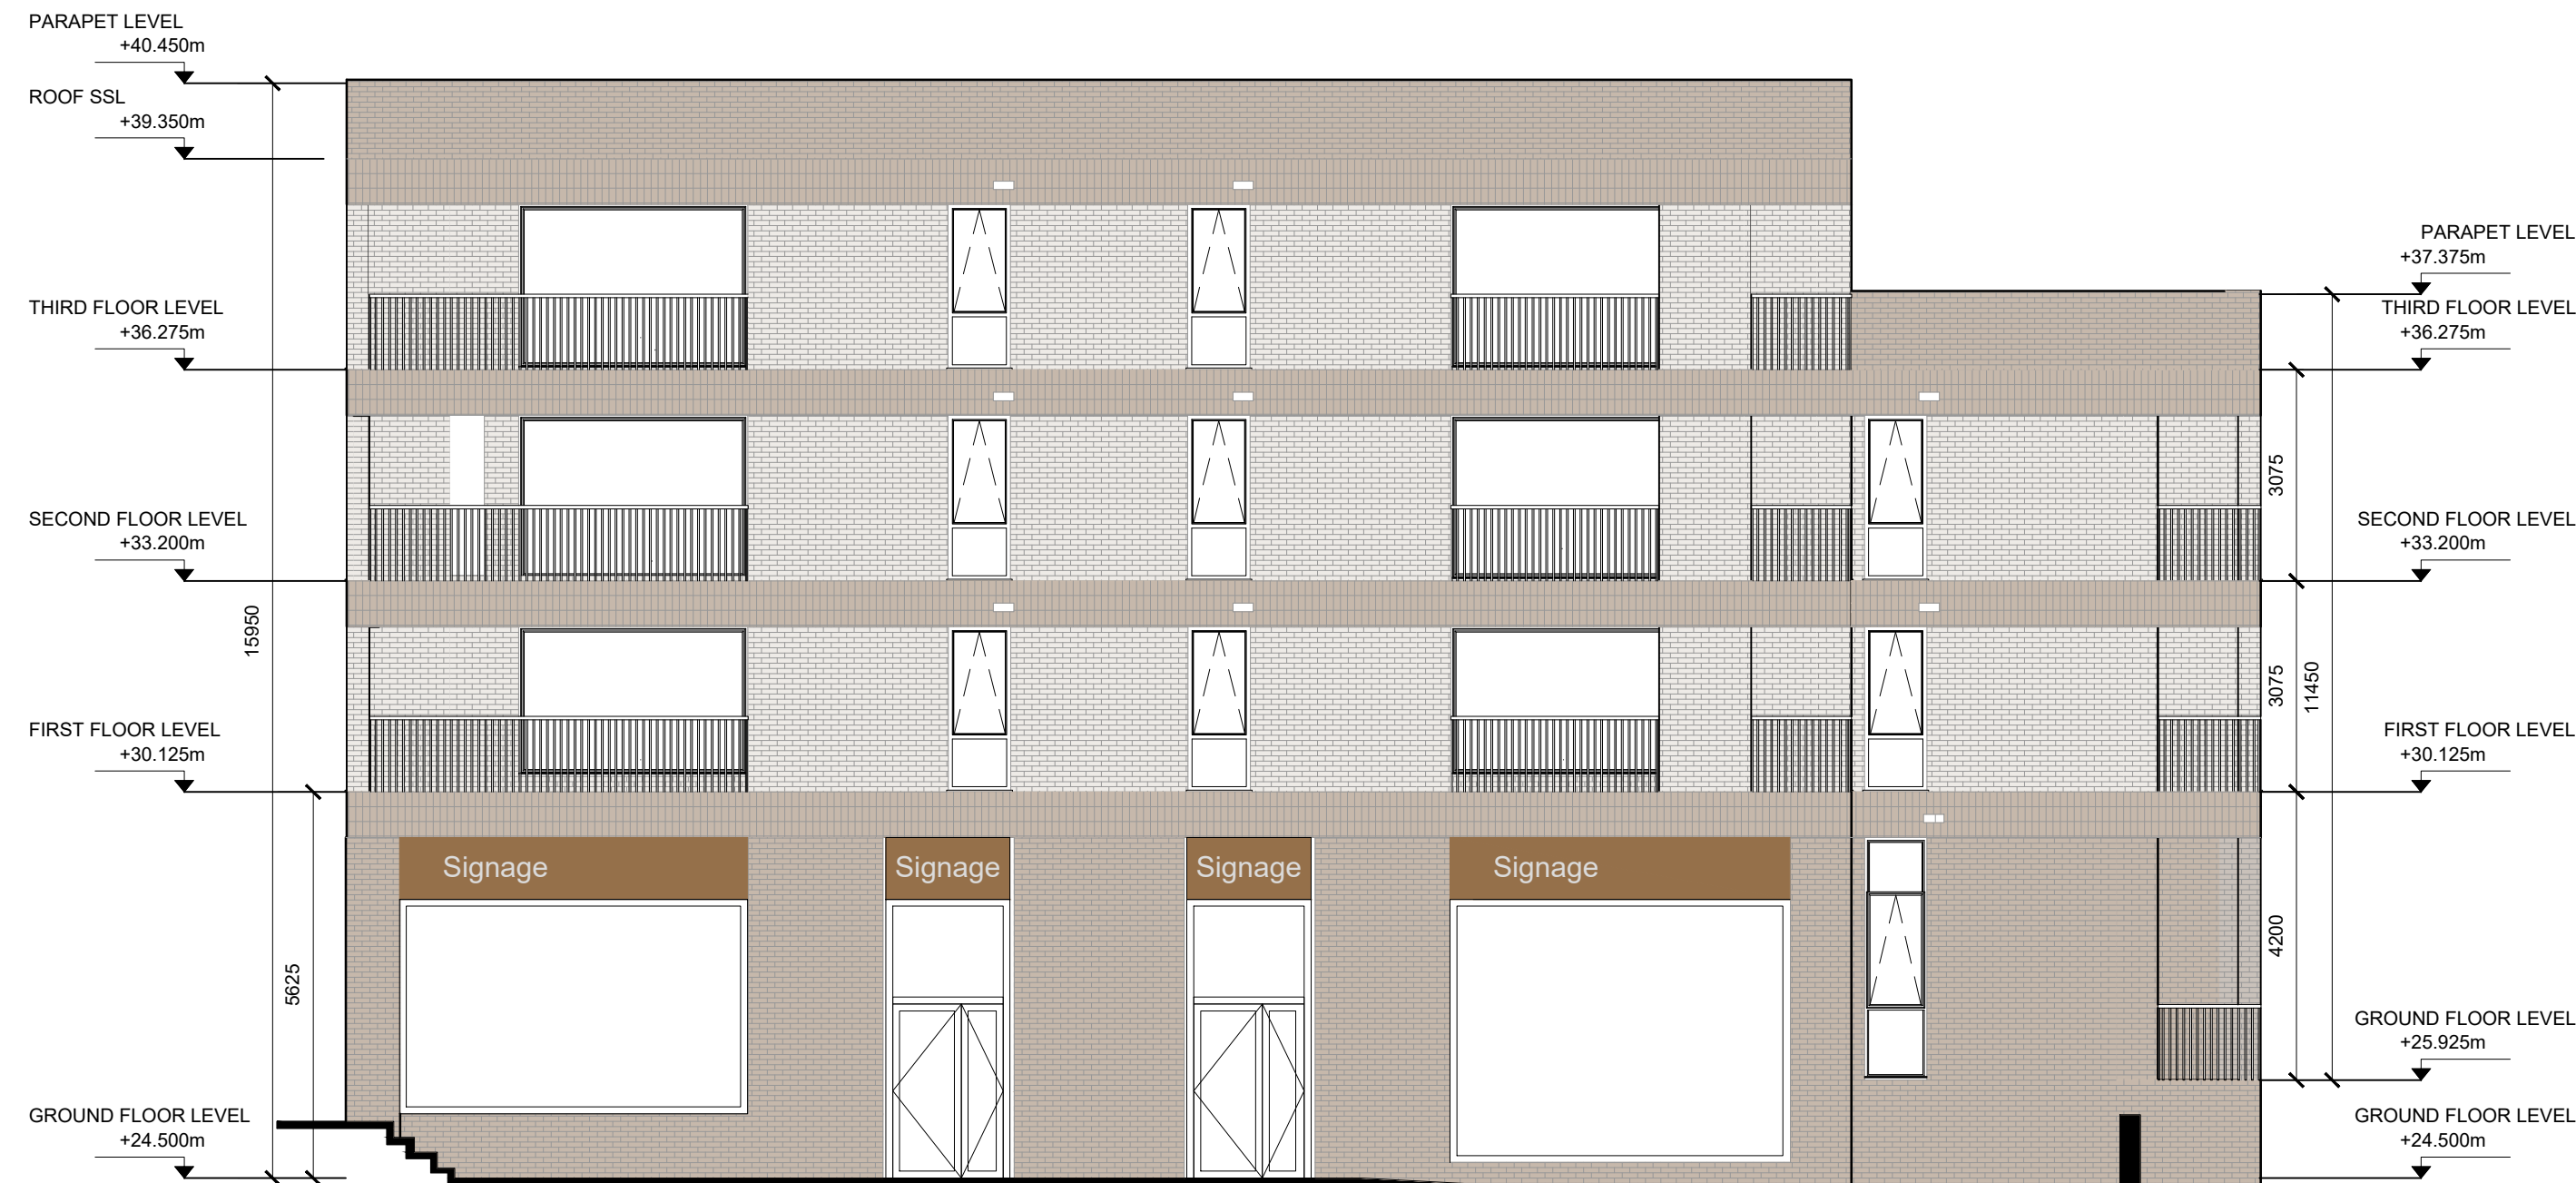

4 Block A - Proposed East Elevation
6304 1:100

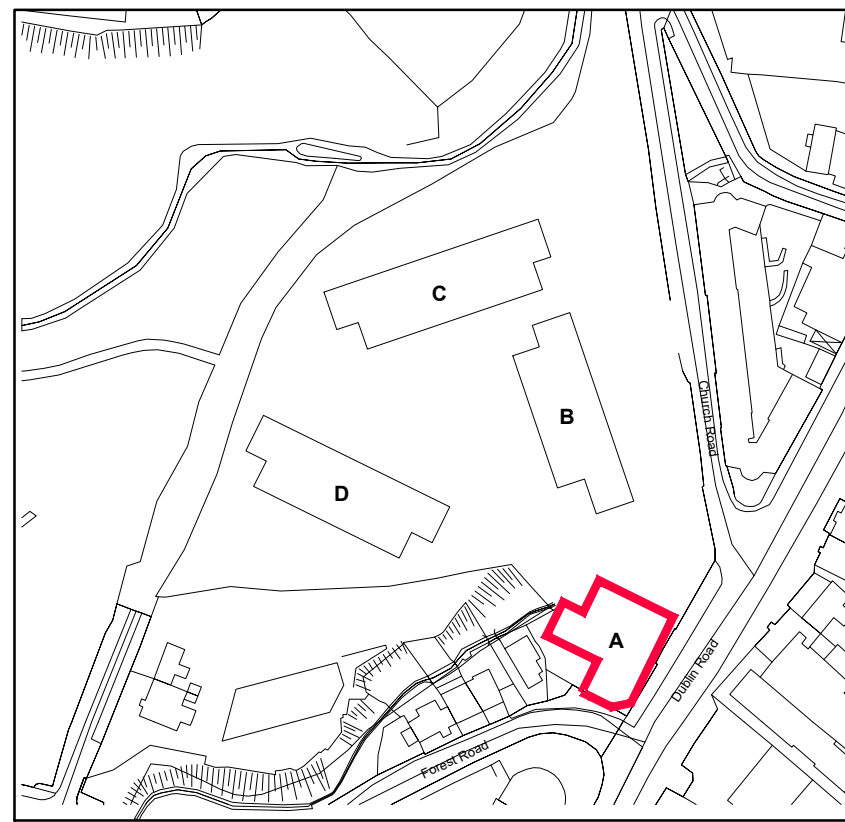

Notes					Issue Status					Revision				
1. Copyright Reserved					Progress					01	03/06/26	ISSUED FOR PLANNING APPLICATION	SB	
2. Work to figure dimensions only. Do not scale drawing.					Planning Application					02	02/09/26	DIMENSIONS ADDED	SB	
3. The contractor is responsible for checking all levels and dimensions on site and shall refer all discrepancies to the Architect.					Fire Cert									
4. Where appropriate, for details of f.c. structure, or mechanical and electrical details, see Engineers drawings.					Disability Cert									
5. Proprietary items shall be fixed in strict accordance with manufacturers instructions.					Tender									
6. Sizes of proprietary items shall be checked with manufacturer.					Construction									
7. The contractor shall be responsible for the coordination of structure, finishes and services.					As Built									
Information Only														
M:\Project Section - Current\6304 Lord Majors\Administration\09 - Planning\Block A Change Of Use\Lord Mayors Proposed Site Plan Ground.dwg 08/09/2026 12:05:46														

Project					Lord Mayors Residential Development				
Drawing Title					Swords				
Drawing No					6304-PL3-A-E002				
Scale					1:100@A1				
Rev					02				
Drawn					sb				
Date					03/06/26				

